


- CABLE/MODEM
- SMOKE DETECTOR
- RECESSED LIGHT
- FLUORESCENT LIGHT
- 110V OUTLET
- 220V OUTLET
- LIGHT FIXTURE
- GROUND FAULT CIRCUIT INTERRUPTER AT BATHS, KITCHENS & ENTRANCES

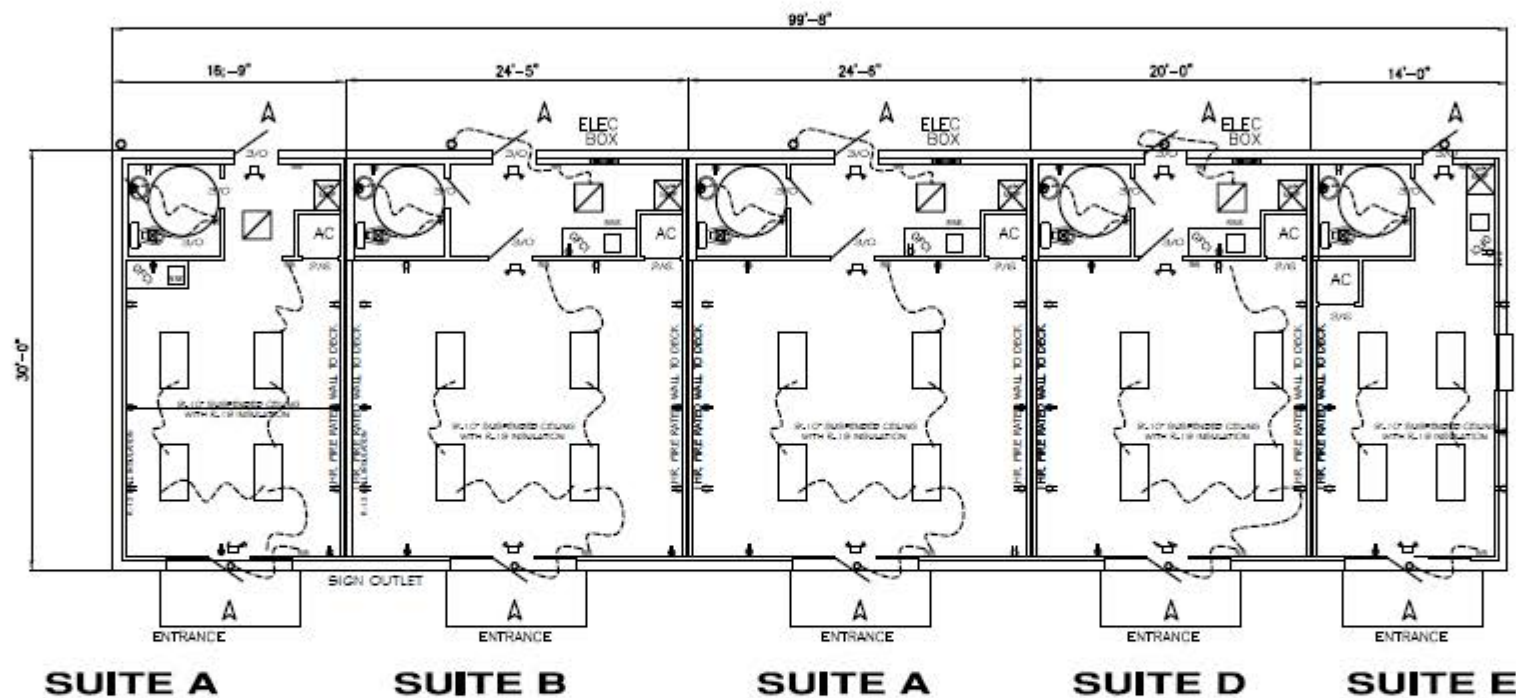

SUITES	
A	500 SQ.FT.
B	735 SQ.FT.
C	735 SQ.FT.
D	600 SQ.FT.
E	420 SQ.FT.
TOTAL 2,990 SQ.FT.	






PROPOSED PROJECT:
LUIS MARTINEZ
 LOT 22, QUAIL CREST SUB'D.
 2001 QUAIL CREST DR.
 PALMVIEW, TEXAS 78674

DRAWN BY:	REVIEW DATE:
CHECKED BY:	3/19/2024
COMPUTER:	5/7/2024
PREPARED BY:	L. GARCIA
FILE:	2021/RTN-SALVADO.DWG

FLOOR PLAN
 SCALE: 3/16" = 1'-0"

SHEET NO.
 2 OF 4

Lamar
 CONSTRUCTION
 1233 E GRIFFIN PARKWAY AVE., MISSION, TEXAS
 (956) 789-4953 lamarconstructionrgv@yahoo.com

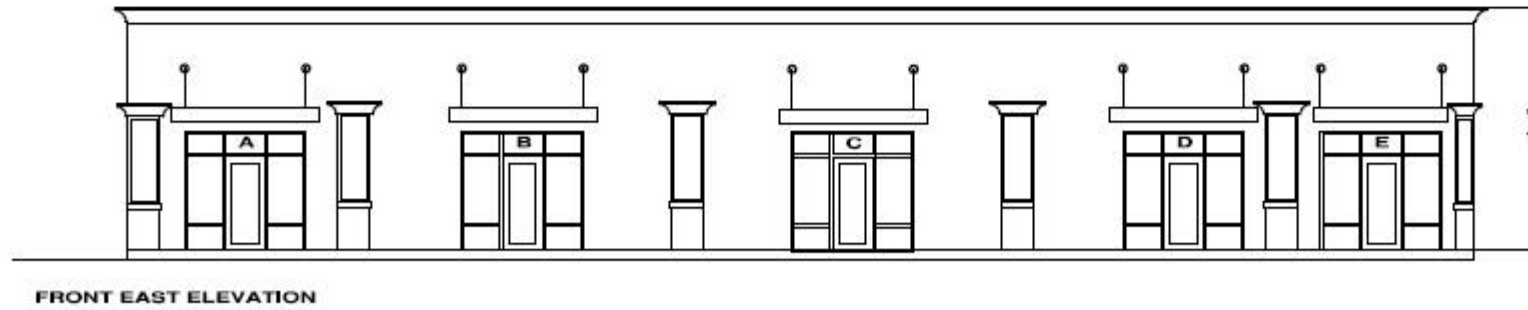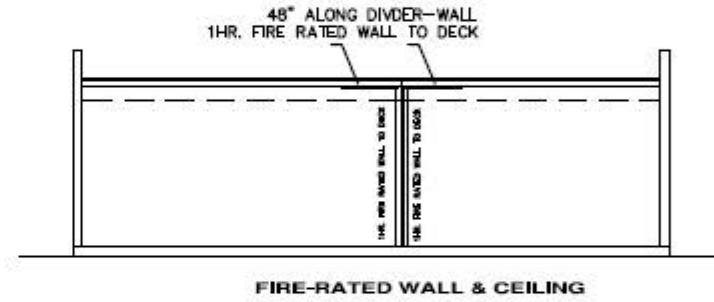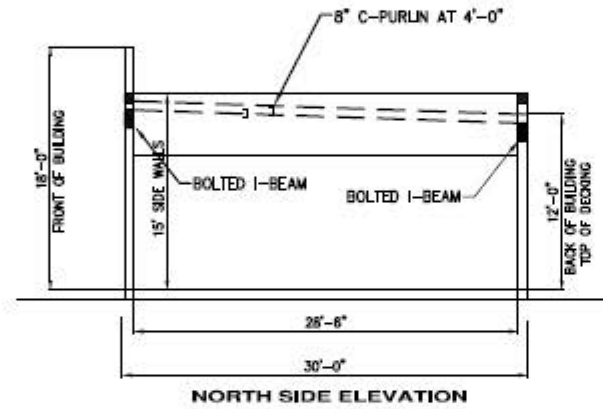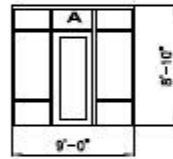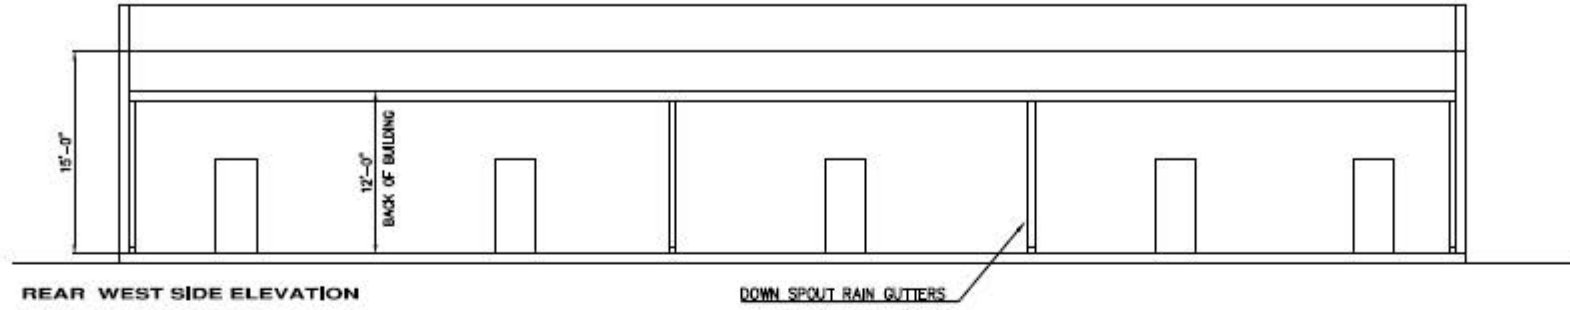

Lamar
CONSTRUCTION

1233 E GRIFFIN PARKWAY AVE., MISSION, TEXAS
(956) 788-1553 lamarconstructiongrv@yahoo.com

PROPOSED PROJECT:
LUIS MARTINEZ
LOT 22, QUAIL CREST SUB'D.
2001 QUAIL CREST DR.
PALMVIEW, TEXAS 78574

DRAWN BY:	REVIEWED DATE:
CHECKED BY:	3/6/2024
COMPUTER:	3/7/2024
PREPARED BY:	L. GARCIA
FILE:	2021/RECK.SAUNAS.DWG

ELEVATION PLAN
SCALE: 3/16" = 1'-0"

SHEET NO.
1 OF 4